



HOT WATER IN - 3/4" COPPER

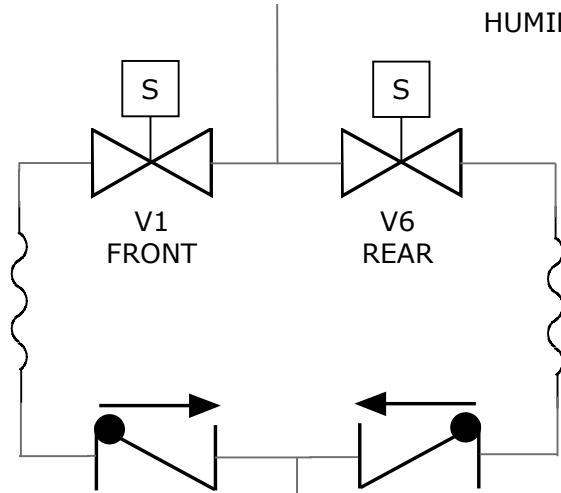


HOT WATER OUT - 3/4" COPPER

COLD WATER IN - 3/4" COPPER

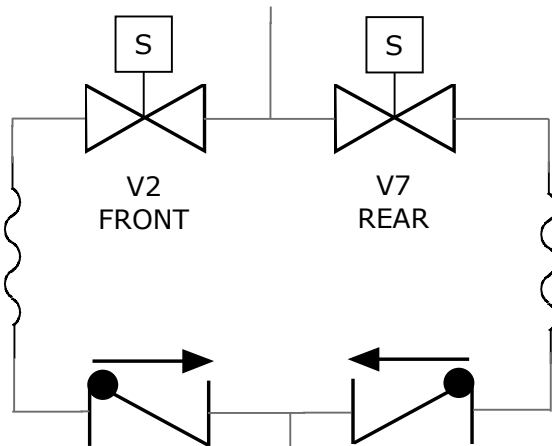

COLD WATER OUT - 3/4" COPPER

HUMIDIFICATION - 3/8" NYLON

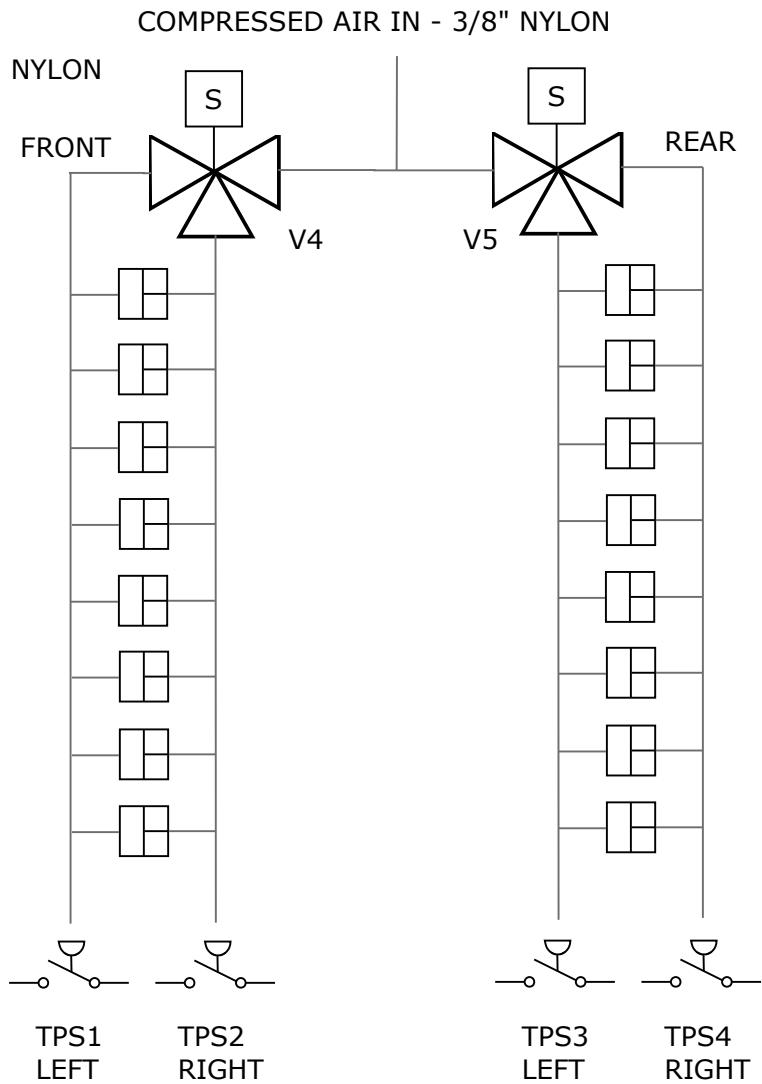


Platinum P80 P & ID


Jamesway Incubator Co. Inc.

DRAWN	CHECKED	DATE	DRAWING NO.
RH		8/19/2014	

Power Wiring for P80 Incubators, 208–240 VAC

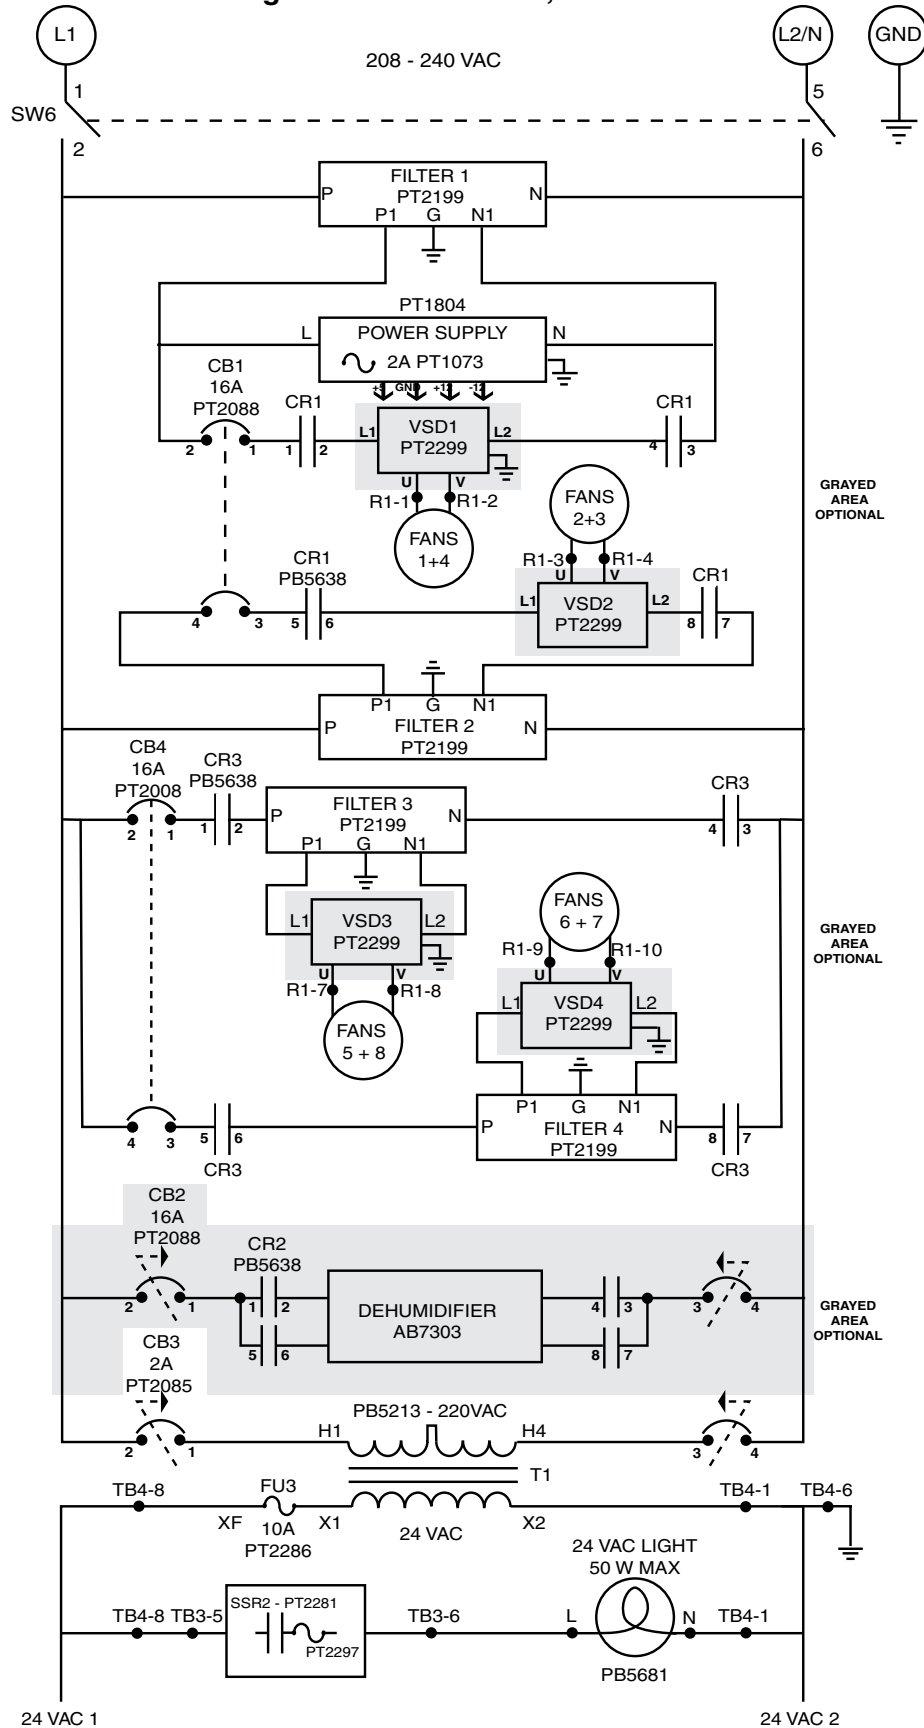


Power Wiring for P80 Incubators, 24 VAC

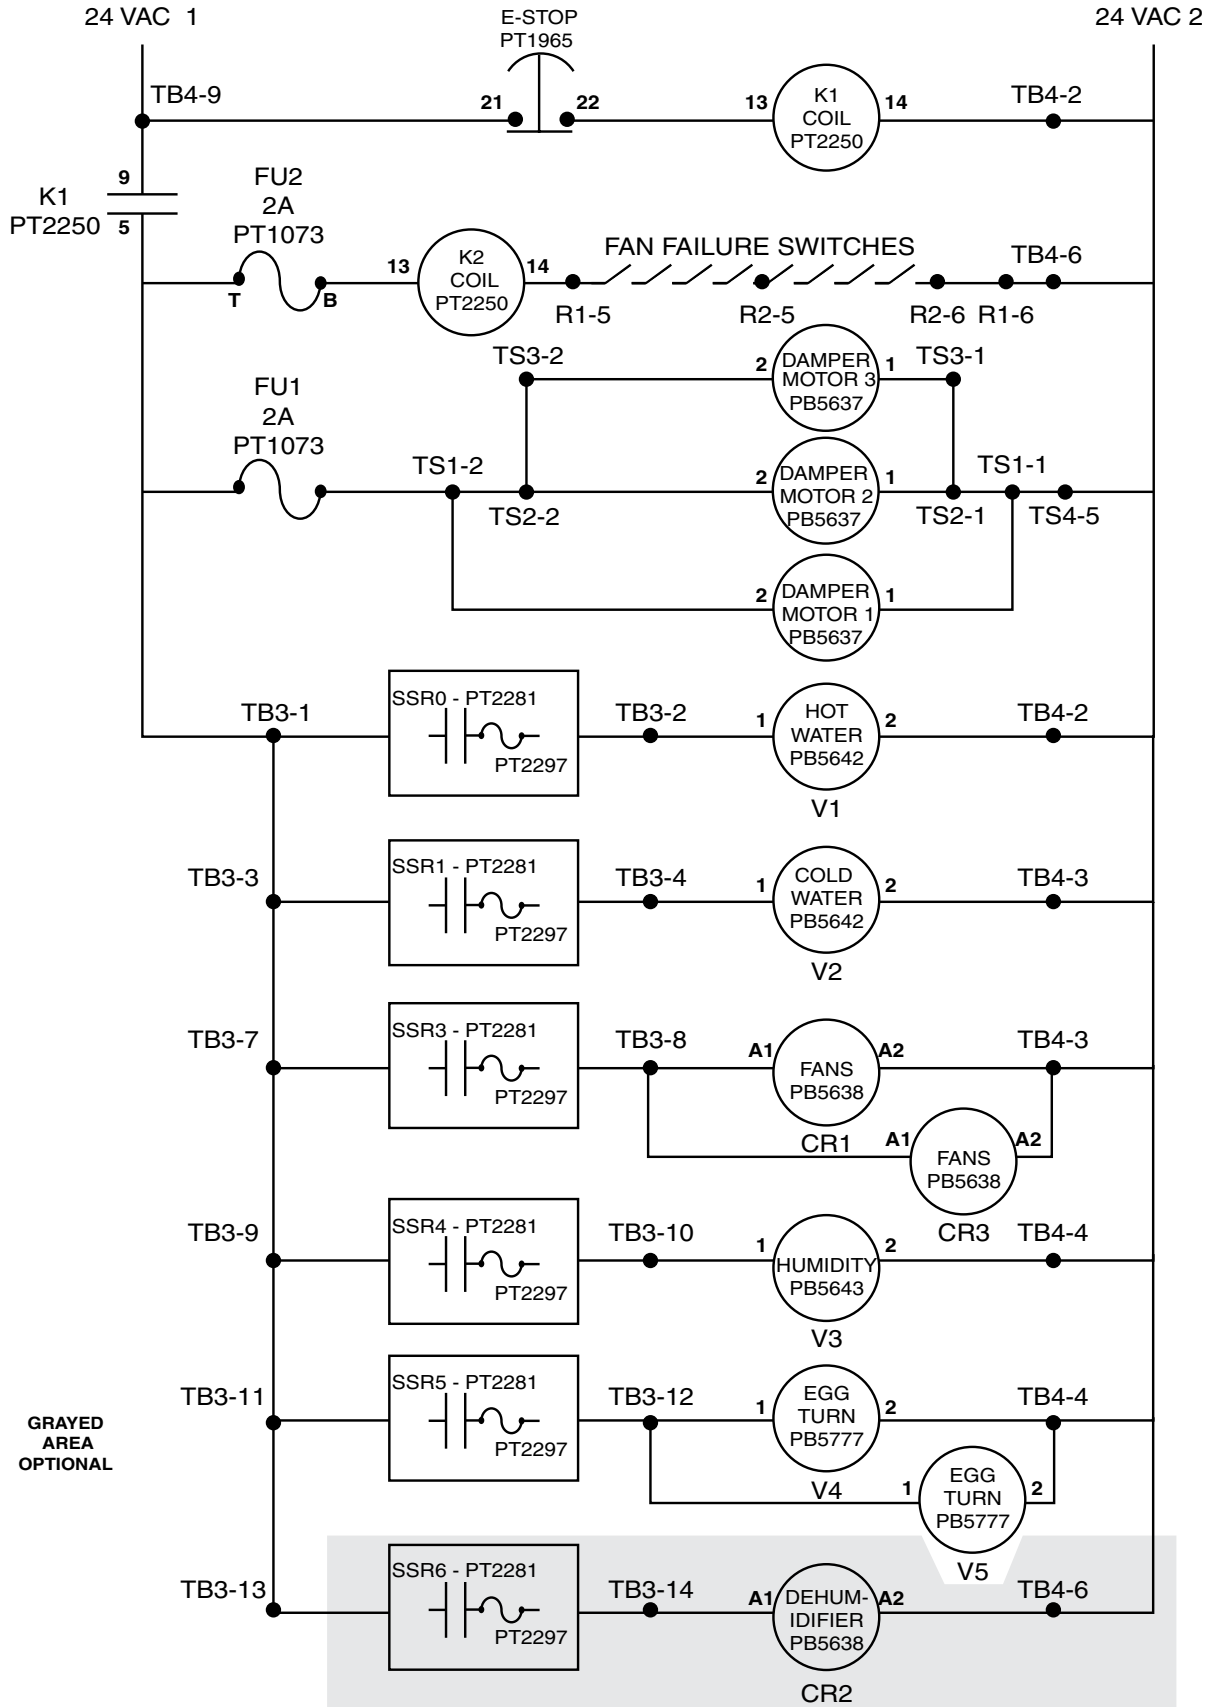


Power Wiring for P80 Incubators, Low Voltage

Note: Since September 2007, boards PT2279 and SMA106 have been replaced with SMA106 board, Revision D or higher.

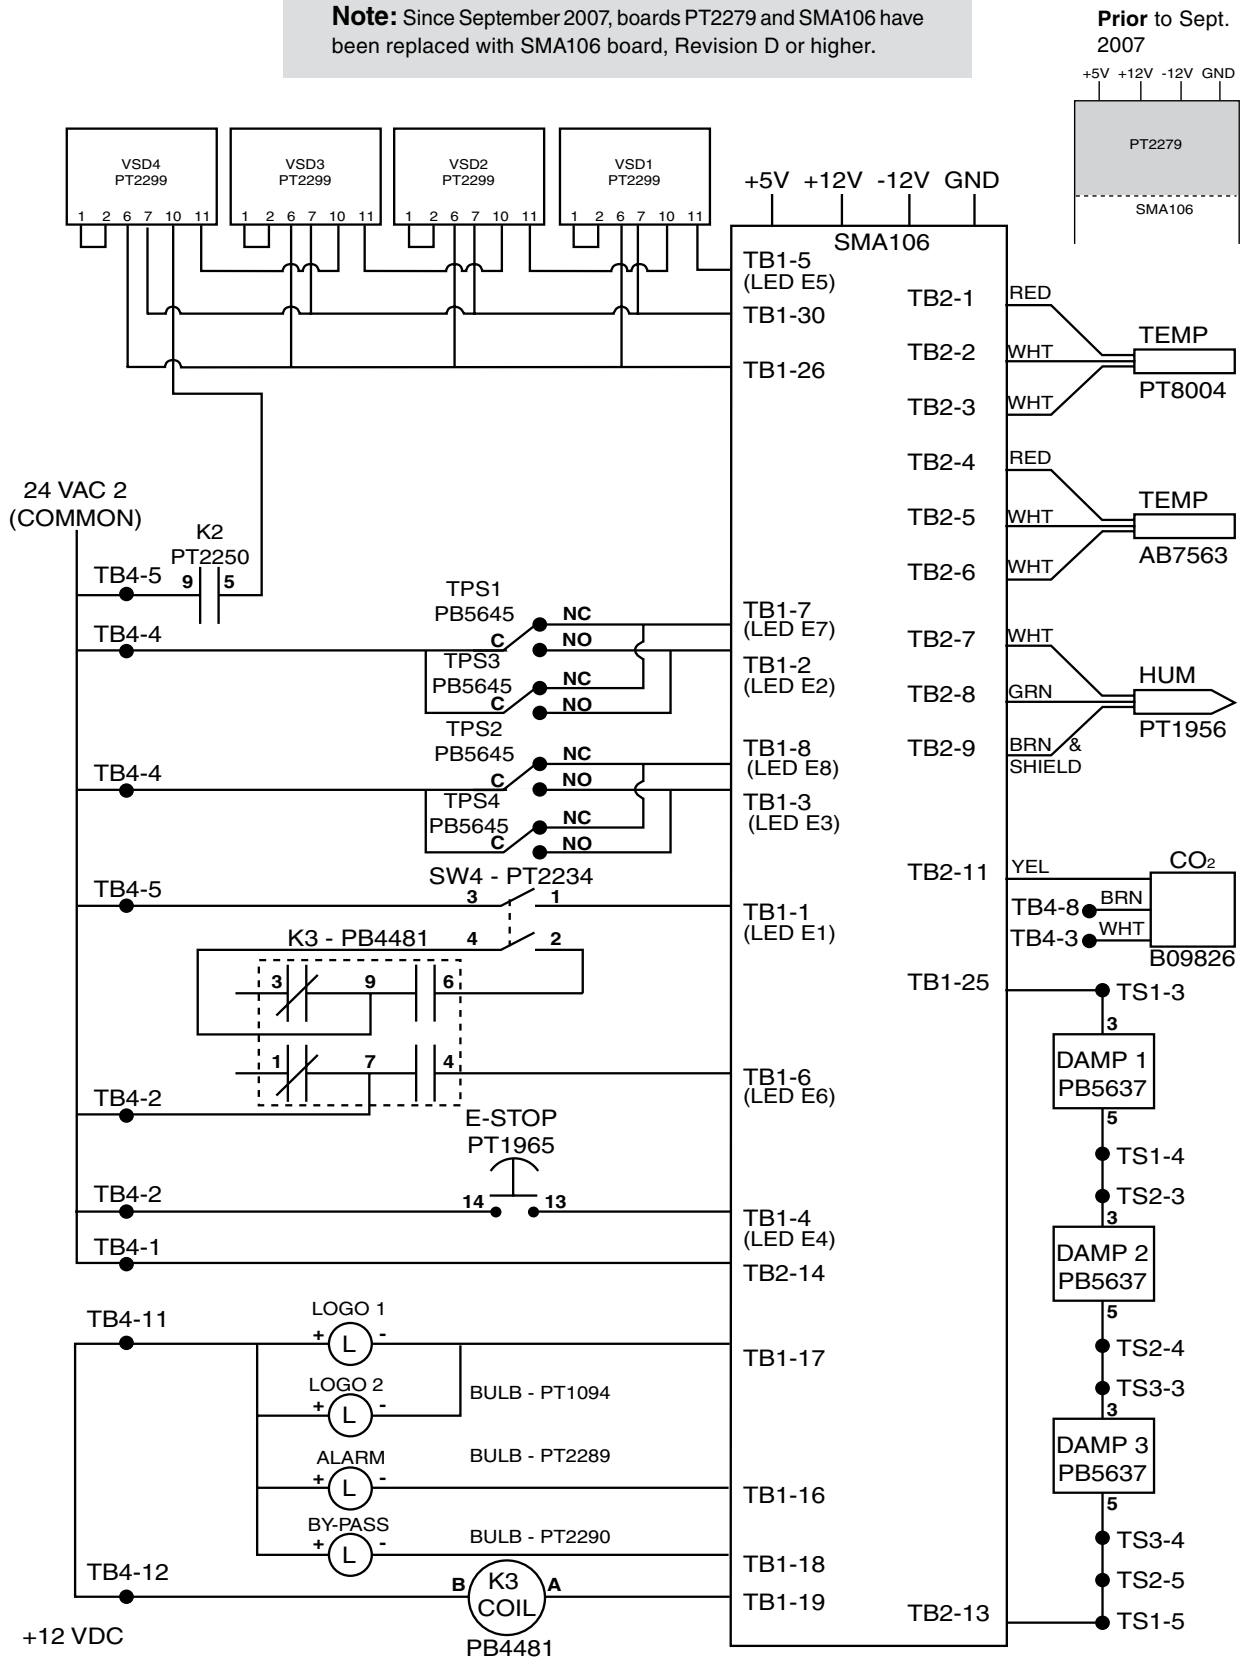

CONTROL BOX, P80 INCUBATORS

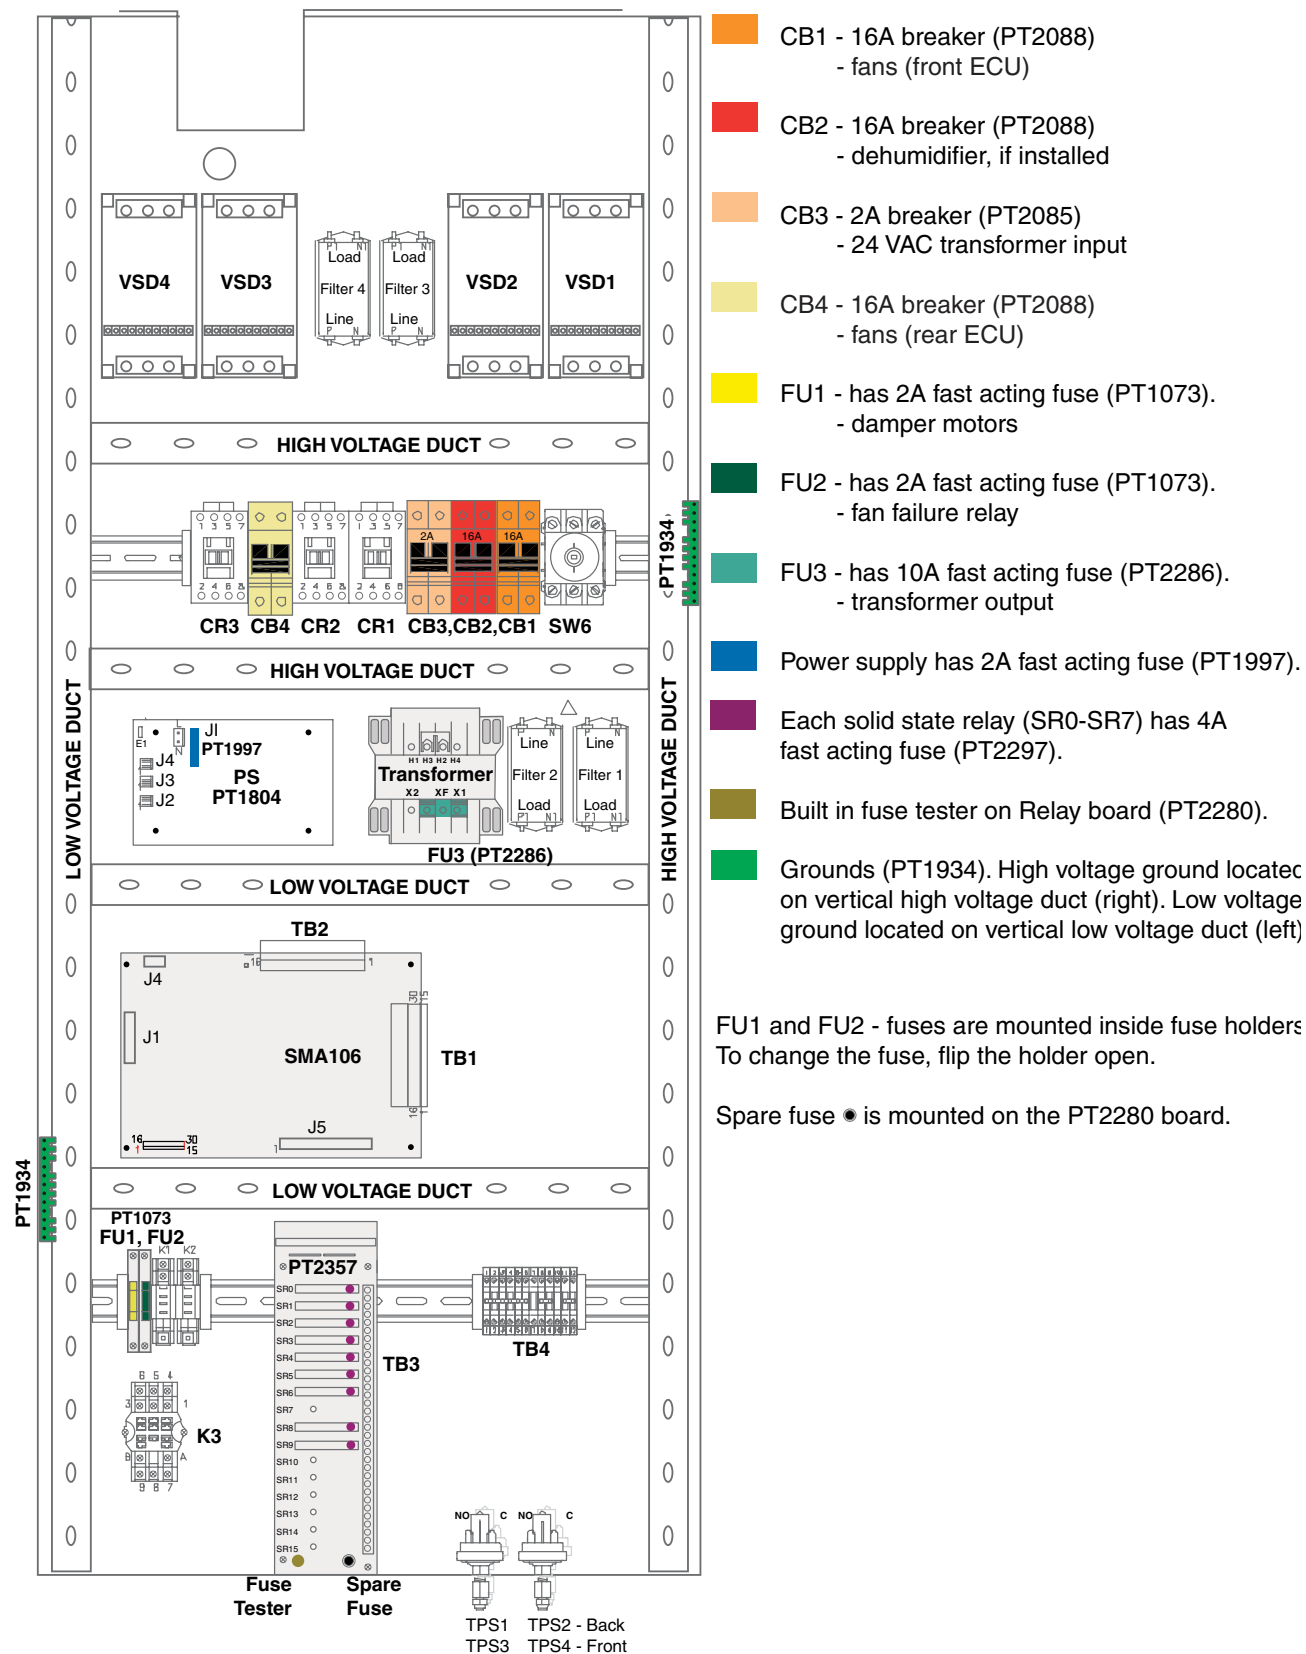

Control Box, P80 Incubators - location of circuit breakers and fuses